
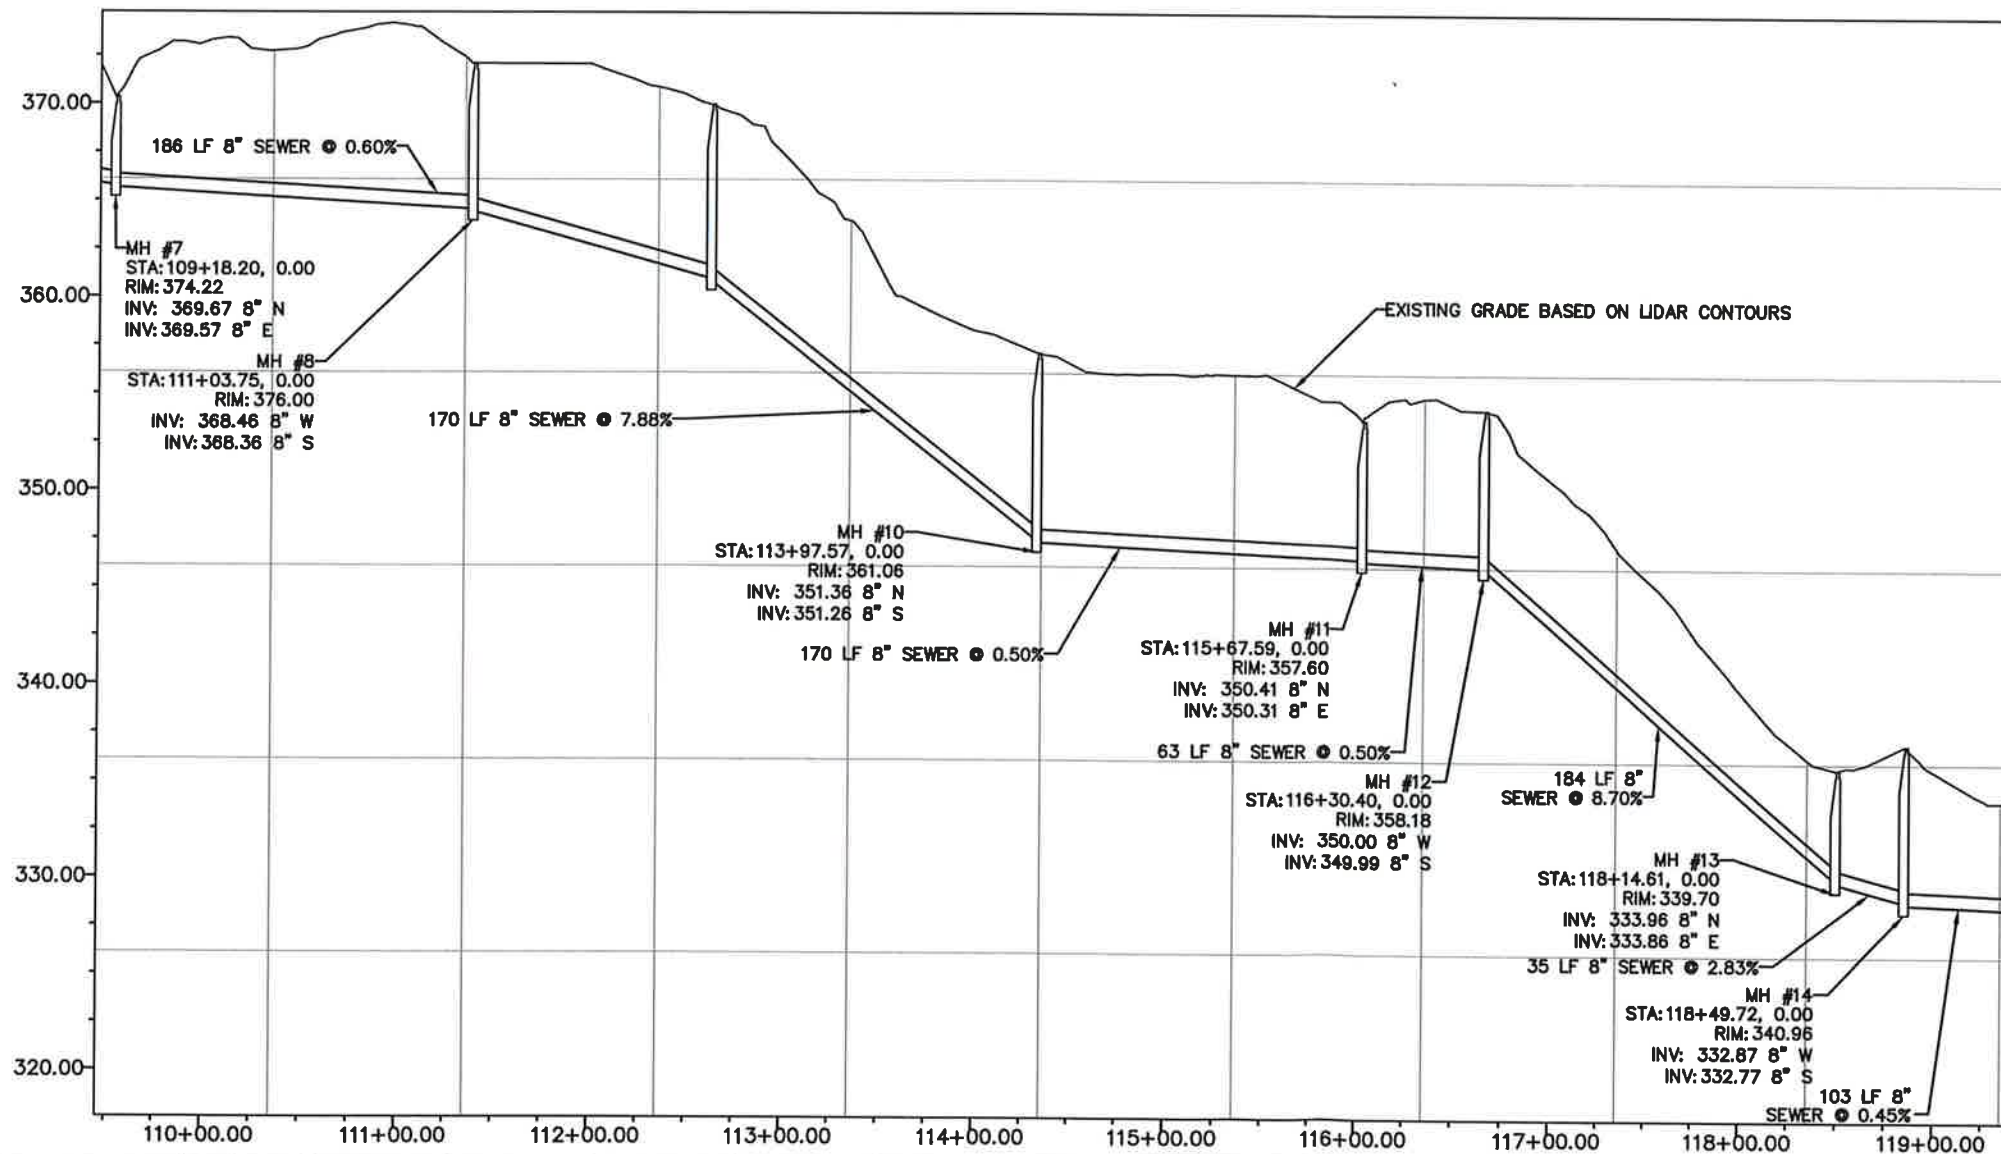
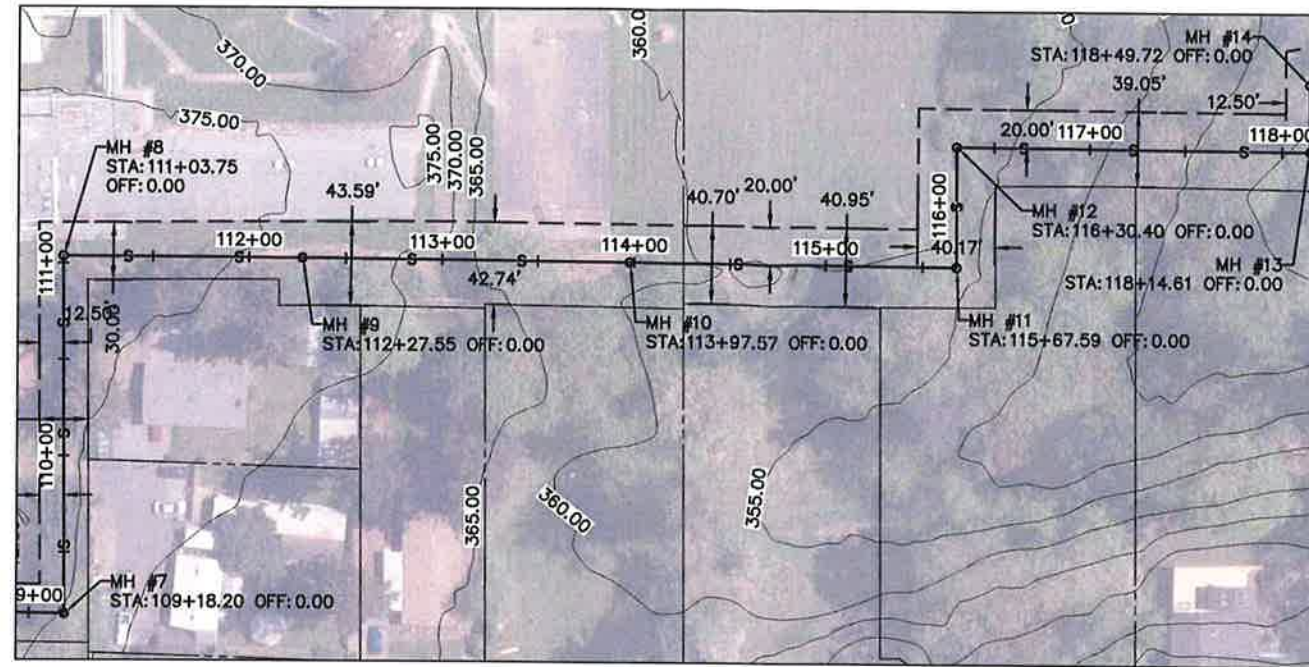


**PRELIMINARY
NOT FOR
CONSTRUCTION**

DESIGNED:		CHECKED:		KENT PROJECT NO. 11-3003	SCALE: HORIZ: 1"=150' VERT: N/A	BAR IS ONE INCH ON ORIGINAL DRAWING ADJUST SCALES ACCORDINGLY	 City of Kent Public Works Department Engineering Division	SKYLINE SANITARY SEWER SHEET KEY MAP	SKYLINE SEWER	SHEET 1 OF 5	FILE NO: SKYLINE_SEWER_PLANS.dwg
DRAWN:		PROJECT ENGR:		CONS. MGMT. REVIEW	DATE						
NO.	REVISION	BY	DATE	APPROVED:	CITY ENGINEER						

SEC. 22, T 22 N, R 4 E



**PRELIMINARY
NOT FOR
CONSTRUCTION**

DESIGNED: _____		CHECKED: _____		KENT PROJECT NO. 11-3003		SCALE: HORIZ: 1"=50'		BAR IS ONE INCH ON ORIGINAL DRAWING ADJUST SCALES ACCORDINGLY		City of Kent Public Works Department Engineering Division	SKYLINE SANITARY SEWER PLAN AND PROFILE	SKYLINE SEWER	SHEET 3 OF 5 FILE NO: SKYLINE_SEWER_PLANS.dwg	
DRAWN: _____		PROJECT ENGR: _____		CONST. MGMT. REVIEW		VERT: 1"=50'								
NO.	REVISION	BY	DATE	APPROVED: _____		CITY ENGINEER		DATE						

